

Republic of the Philippines
DEPARTMENT OF SOCIAL WELFARE AND DEVELOPMENT
Cordillera Administrative Region
40 North Drive, Baguio City

REQUEST FOR QUOTATION (RFQ)

PR/PP No.: 2022-09-540

End-user: RICTMS

Name of Project:

RFQ No.: 2022-09-712

Date: SEP 16 2022

ABC: ₱160,000.00

**PURCHASE OF MOBILE SIGNAL BOOSTER INCLUSIVE OF FREE
INSTALLATION**

Mode of Procurement: SMALL VALUE PROCUREMENT

Sir/Madam:

Please quote your lowest price on the item/s described below inclusive of taxes duly signed by you or your authorized representative, subject to the Terms and Condition provided in this RFQ and submit personally to the Office of the Procurement Section, 40 North Drive, Baguio City or through email at bacsec.car@dswd.gov.ph on or before

12:00NN.

SEP 20 2022

ENRIQUE H. GASCON JR. *no*
BAC Chairperson *ym*

TERMS AND CONDITIONS:

1. Quotations in excess of the ABC will be **REJECTED**.
2. For total quoted price, quotations with a **dash or zero shall be deemed free of charge**.
3. All entries must be typewritten/printed/longhand. **Any erasure in the quotation must be countersigned by the bidder/representative**, otherwise quotation will be rejected.
4. The Procuring Entity may **give due preference to goods being offered with green component**.
5. If necessary, the BAC through the TWG, may require an ocular inspection of the venue/place of business/goods being offered.
6. Delivery of Goods / Services is **as indicated** in the next page.
7. Price validity shall be for a period of **120 calendar days from RFQ Opening of the BAC until confirmation of Purchase Order by the winning supplier**.
8. The following documents shall be attached upon submission of quotation, otherwise your quotation will not be accepted, please disregard if already submitted:
 - a. **Updated Mayor's / Business Permit**
 - b. **PhilGEPS Registration Certificate or PhilGEPS Registration Number to be indicated in space below (except for Negotiated Procurement - Emergency Cases, Sec. 53.2, RA 9184 IRR)**
 - c. **Income/Business Tax Return (for Small Value Procurement, Direct Contracting above P500K, Emergency Cases above P500K, and Lease of Real Property/Venue).**
 - d. **Official Receipt issued by BIR(a mere picture of the receipt can suffice)**
9. Where there is discrepancy between: (a) total price per item and unit price for the item as extended or multiplied by the quantity of that item, the unit price shall prevail; (b) stated total price and the actual sum of prices of component items, the lower shall prevail; (c) unit cost in the detailed estimate and unit cost in the bill of quantities, the lower shall prevail.
10. Suppliers/Contractors who **refuse to accept correction of price offer after Bid Evaluation shall be disqualified**.
11. Award of Contract shall be made to the Lowest Calculated Responsive Quotation (LCRQ) that complies to the **technical specifications** and the **terms and conditions** stated herein.
12. The BAC shall require the bidder with Lowest Calculated Responsive Quotation (LCRQ) to submit the Omnibus Sworn Statement prior to issuance of Award / Purchase Order with ABC amounting to P500,000.00 for Emergency Cases and P50,000.00 above for Small Value Procurement .
13. If the Supplier fails to deliver the required goods /services as specified in the Award / Purchase Order, the Procuring Entity may **disqualify bidder from participating future procurement activities to be conducted by DSWD-CAR**.
14. **Liquidated damages equivalent to one tenth of one percent (0.001)** of the value of the goods not delivered within the prescribed delivery period may be imposed per day of delay. The Procuring Entity (PE) may rescind the contract once the cumulative amount of liquidated damages reaches ten percent (10%) of the amount of the contract, without prejudice to other courses of action and remedies open to it.
15. Further information may be obtained from the Procurement Section with telephone number **(074) 661-0430 local 25025** or email address bacsec.car@dswd.gov.ph.

Republic of the Philippines
DEPARTMENT OF SOCIAL WELFARE AND DEVELOPMENT
Cordillera Administrative Region
40 North Drive, Baguio City

REQUEST FOR QUOTATION (RFQ)

| LOT NO. | DETAILED DESCRIPTION | QTY | UNIT | UNIT PRICE | TOTAL |
|---|---|--|----------------------|------------|----------------|
| 1 | PURCHASE OF MOBILE SIGNAL BOOSTER INCLUSIVE OF FREE INSTALLATION | | | | |
| | Technical Specifications: Mobile 2g/3g/4g LTE cellular signal repeater Gain: ≥70dB DL; ≥65dB UL Output power: atleast 65dB UL GSM: 890-915mhz UL; 935-960mhz DL DCS: 1710-1785mhz UL; 1805-1880mhz DL WCDMA: 1920-1980mhz UL; 2110-2170mhz DL Impedance: 50 Ohm Connector Type: N female connector RJ45 10Base-T/100 Base-TX PoE (Please see attached proposed installation plan) | 4 | piece | | |
| | OTHER REQUIREMENTS | COMPLIANCE <i>please check (✓) whether can comply or not, no check mark will mean non-compliance</i> | | | REMARKS |
| | | Can Comply | Cannot Comply | | |
| | <i>The service provider shall facilitate installation, testing and commissioning</i> | [] | [] | | |
| | <i>The service provider shall include conduits</i> | [] | [] | | |
| | <i>Completion of project is within 45 calendar days upon receipt of Purchase Order. When the last day of delivery falls on a weekend/holiday, the deadline shall be on the next working day.</i> | [] | [] | | |
| | <i>Service Provider must have an Active Landbank Account for Payment Purposes. For other banks, service charge will be deducted upon payment on the account.</i> | [] | [] | | |
| PAYMENT SHALL BE MADE THRU LANDBANK OF THE PHILIPPINES | | | | | |
| TOTAL PRICE | | | | | |

• Award shall be made per: Lot basis Total Quoted Price

Note: NO GIFT ALLOWED. Pursuant to RA 6713, otherwise known as the Code of Conduct and Ethical Standards for Public Officials

Sir:

After having carefully read and accepted your terms and conditions, I / We submit our bid on the item/s quoted above.

*Signature of
supplier/representative over
printed name:* _____

*Name of
Firm/Dealer/Contractor:* _____

(This will be the name of the CHEQUE to be issued)


Name and Signature of Convasser

Address: _____
Email Address: _____

Contact Number/s: _____

PhilGEPS Registration Number: _____



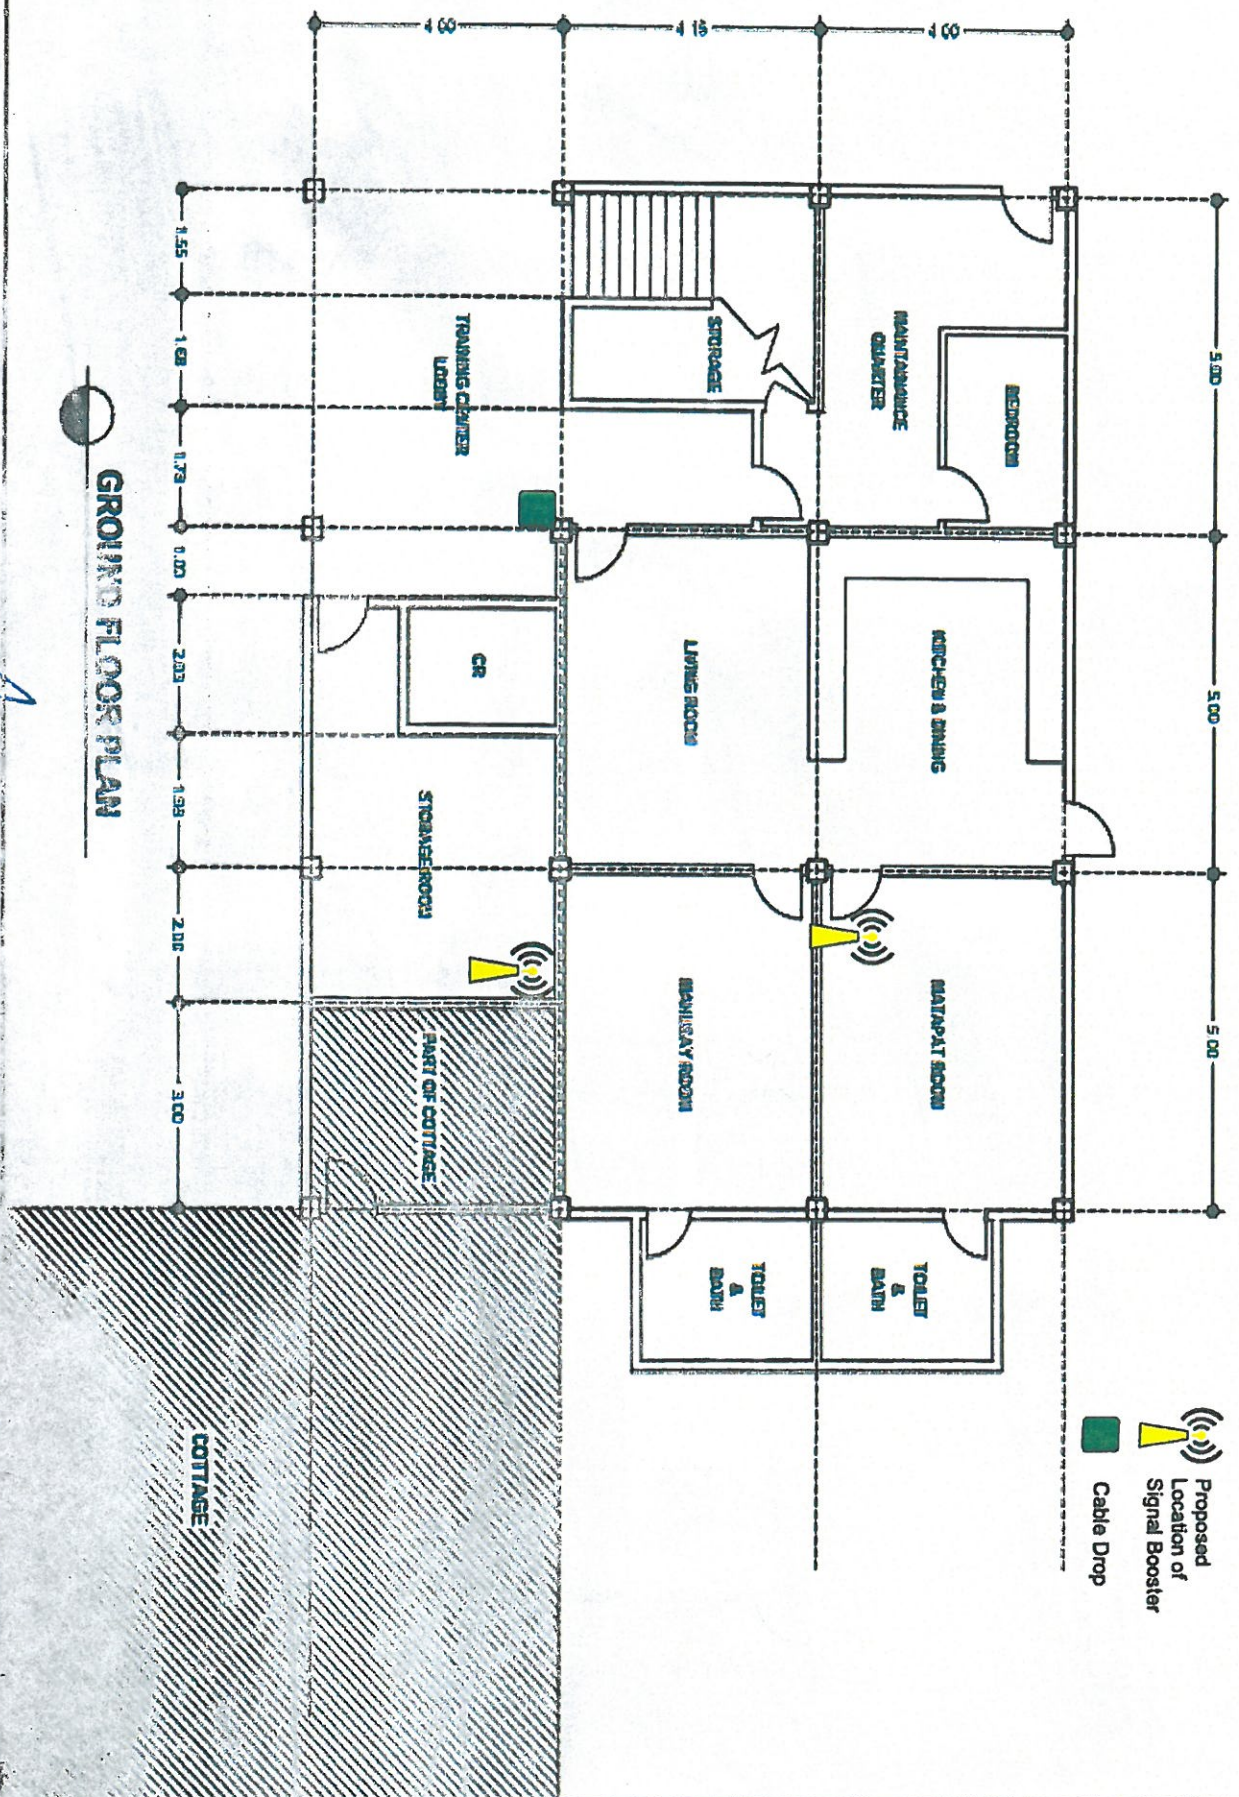

GROUND FLOOR PLAN

-  Proposed Location of Signal Booster
-  Cable Drop

PREPARED BY:

HAMLET CAMAYONA
ITO II - ICTS

RECOMMENDED BY:

ENRIQUE H. GARCIA JR.
DIRECTOR JR - HR & ADMINISTRATION

APPROVED BY:


LEO L. QUINTILLAN JR.
REGIONAL DIRECTOR

Handwritten signature/initials

Proposed Location of Signal Booster



Cable Drop

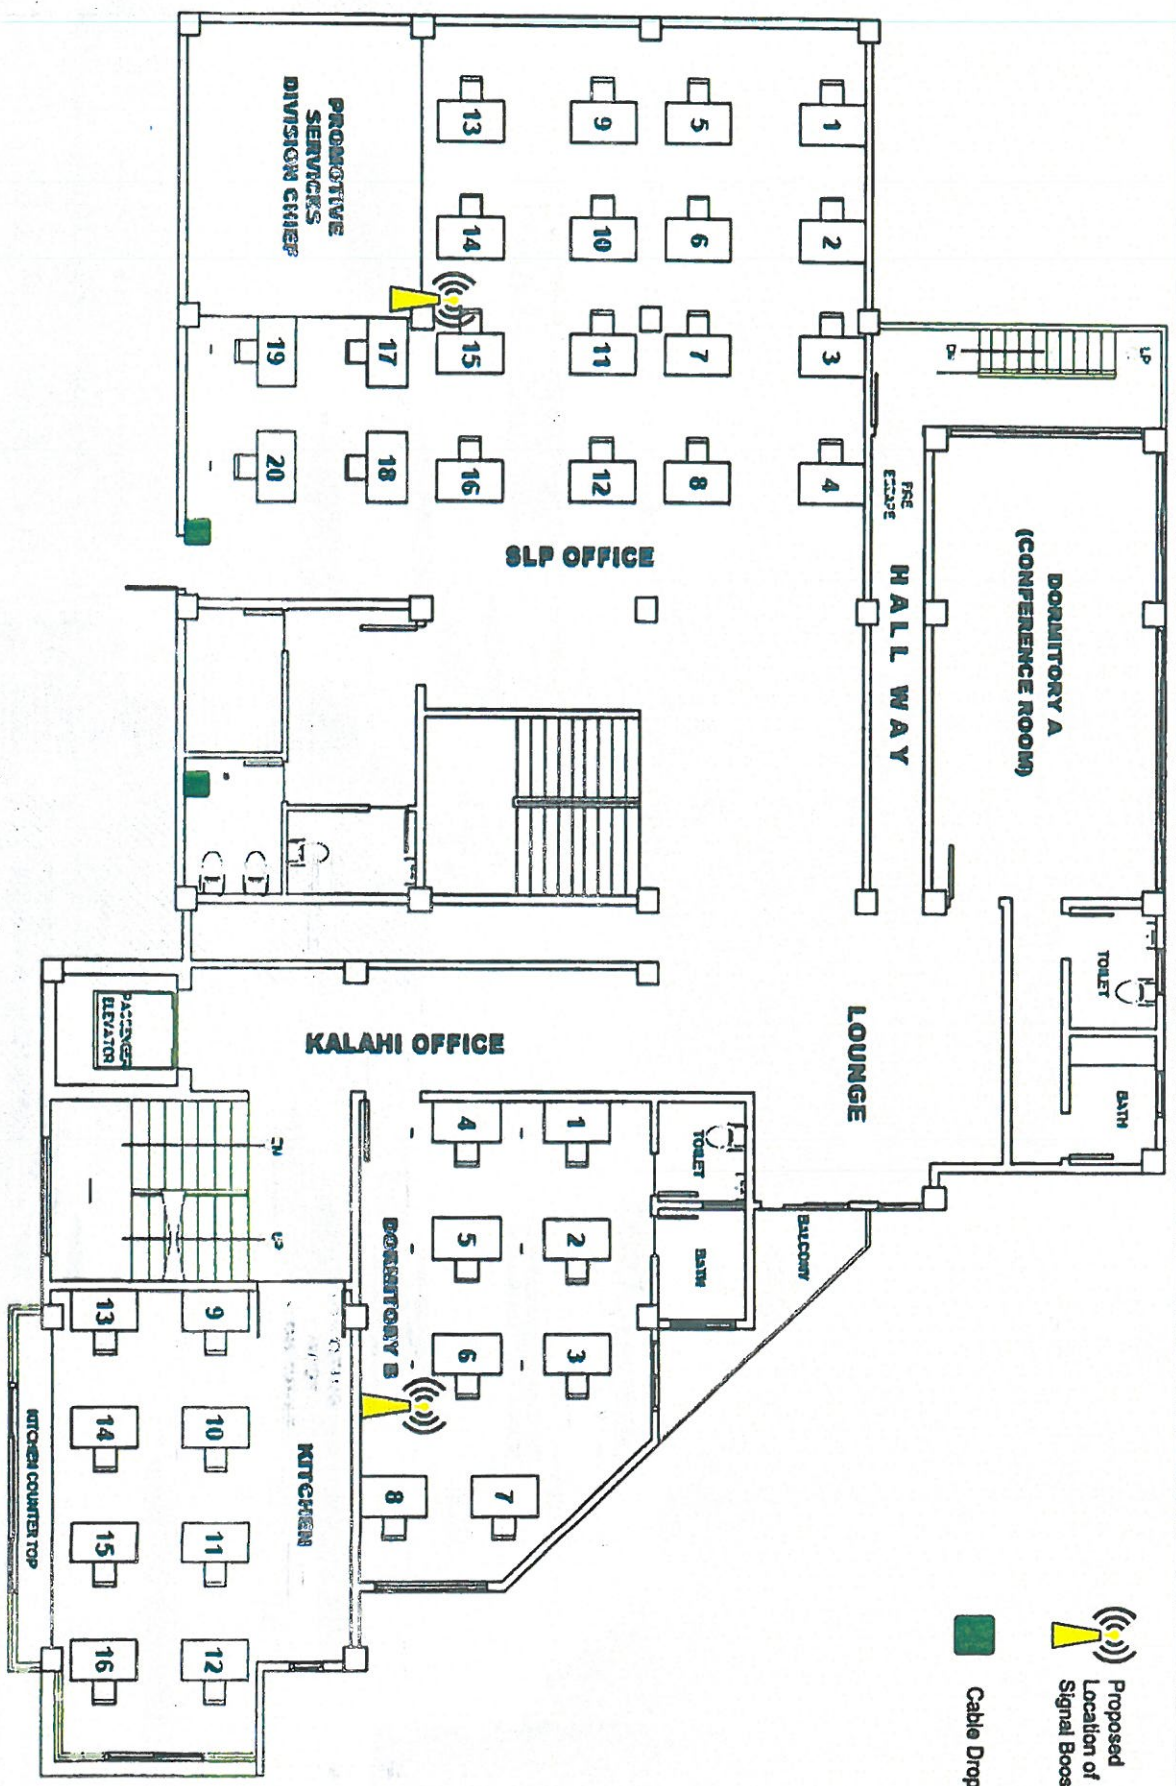

SCALE 1:1000
SECOND FLOOR PLAN (TRAINING CENTER)

PREPARED BY:

HAMLET C. MAYONA
 TOLL-ICTS

RECOMMENDING APPROVAL:

ENRIQUE H. BASCO
 DIRECTOR OF OFFICE ADMINISTRATION

APPROVED:

LEO L. QUINTANA
 REGIONAL DIRECTOR