

REQUEST FOR QUOTATION (RFQ)

PR/PP No.: 2022-11-679
End-user: RICTMS
Name of Project:

RFQ No.: 2022-11-869
Date: NOV 17 2022
ABC: P991,574.06

**PURCHASE AND INSTALLATION OF IT EQUIPMENT FOR THE
IMPROVEMENT OF THE VISUAL PRESENTATION SYSTEM OF THE
MULTI-PURPOSE HALL OF RHWG PHASE II**

Mode of Procurement: SMALL VALUE PROCUREMENT

Sir/Madam: _____

Please quote your lowest price on the item/s described below inclusive of taxes duly signed by you or your authorized representative, subject to the Terms and Condition provided in this RFQ and submit personally to the Office of the Procurement Section, 40 North Drive, Baguio City or through email at bacsec.car@dswd.gov.ph on or before NOV 22 2022 12:00NN.


ENRIQUE H. GASCON JR.
BAC Chairperson JK

TERMS AND CONDITIONS:

1. Quotations in excess of the ABC will be **REJECTED**.
2. For unit price/s, quotations with a dash or zero shall be deemed free of charge.
3. All entries must be typewritten/printed/longhand. **Any erasure in the quotation must be countersigned by the bidder/representative**, otherwise quotation will be rejected.
4. The Procuring Entity may give due preference to goods being offered with green component.
5. If necessary, the BAC through the TWG, may require an ocular inspection of the venue/place of business/goods being offered.
6. Delivery of Goods / Services is **as indicated** in the next page.
7. Price validity shall be for a period of **120 calendar days** from RFQ Opening of the BAC until confirmation of Purchase Order by the winning supplier.
8. The following documents shall be attached upon submission of quotation, otherwise your quotation will not be accepted, please disregard if already submitted:
 - o **PhilGEPS Platinum Membership (if not available, Please submit the following items a and b)**
 - a. **Updated Mayor's / Business Permit**
 - b. **PhilGEPS Registration Certificate or PhilGEPS Registration Number to be indicated in space below (except for Negotiated Procurement - Emergency Cases, Sec. 53.2, RA 9184 IRR)**
 - o **Income/Business Tax Return (for Small Value Procurement, Direct Contracting above P500K, Emergency Cases above P500K, and Lease of Real Property/Venue).**
 - o **Official Receipt issued by BIR (a mere picture of the receipt can suffice)**
9. Where there is discrepancy between: (a) total price per item and unit price for the item as extended or multiplied by the quantity of that item, the unit price shall prevail; (b) stated total price and the actual sum of prices of component items, the lower shall prevail; (c) unit cost in the detailed estimate and unit cost in the bill of quantities, the lower shall prevail.
10. Suppliers/Contractors who **refuse to accept correction of price offer after Bid Evaluation** may be disqualified.
11. Award of Contract shall be made to the Lowest Calculated Responsive Quotation (LCRQ) that complies to the **technical specifications** and the **terms and conditions** stated herein.
12. The BAC shall require the bidder with Lowest Calculated Responsive Quotation (LCRQ) to submit the Omnibus Sworn Statement prior to issuance of Award / Purchase Order with ABC amounting to P500,000.00 for Emergency Cases and P50,000.00 above for Small Value Procurement.
13. If the Supplier fails to deliver the required goods /services as specified in the Award / Purchase Order, the Procuring Entity may **disqualify bidder from participating future procurement activities to be conducted by DSWD-CAR.**
14. **Liquidated damages equivalent to one tenth of one percent (0.001)** of the value of the goods not delivered within the prescribed delivery period may be imposed per day of delay. The Procuring Entity (PE) may rescind the contract once the cumulative amount of liquidated damages reaches ten percent (10%) of the amount of the contract, without prejudice to other courses of action and remedies open to it.
15. Further information may be obtained from the Procurement Section with telephone number **(074) 661-0430 local 25025** or email address **bacsec.car@dswd.gov.ph**.

Republic of the Philippines
DEPARTMENT OF SOCIAL WELFARE AND DEVELOPMENT
Cordillera Administrative Region
40 North Drive, Baguio City

REQUEST FOR QUOTATION (RFQ)

LOT NO.	DETAILED DESCRIPTION	QTY	UNIT	BRAND OFFERED	UNIT PRICE	TOTAL
PURCHASE AND INSTALLATION OF IT EQUIPMENT FOR THE IMPROVEMENT OF THE VISUAL PRESENTATION SYSTEM OF THE MULTI-PURPOSE HALL OF RHWG PHASE II						
1	Video Wall					
1.a	55" Video Wall '-Visual Angle Horizontal: 178°, Vertical: 178° Screen Moving Area (HxV) 1209.6mmx680.4mm(47.62" x 26.79") Response Time 12ms (G to G) Resolution 1920 x 1080 Panel IPS Dot Pitch (HxV) 0.63mmx0.63mm (0.025" x 0.025") Diagonal Size (Inch) 55" LED Backlight (Direct type) Input Interface VGA x 1, DVI x 1, BNC x 1, YPbPr x 1, HDMI x 1 Output Interface VGA x 1, DVI x 1, BNC x 2 Operating Temperature 0 °C~ 40 °C (32 °F- 104 °F) Power Requirement 90~ 264VAC Power Consumption 192W Bezelwidth: ≥1.8mm	4	pcs			
1.b	-HDMI 2.1 (3 Meters)	5	pcs			
1.c	-HDMI 2.1 (30 Meters)	1	pcs			
1.d	-2x2 Display Processor 1 HDMI input 4 HDMI output	1	pcs			
2	Amplifier					
2.a	-6 Channel Powered Mixer with Multi FX Processor and FBQ feedback Detection System	1	pcs			
2.b	-Rack Cabinet	1	pcs			
2.c	-AC Automatic Voltage Regulator	1	pcs			
2.d	-AC Power Sequencer w/ Display	1	pcs			
2.e	-8 Pin Din Male to Male Speaker Audio cable adaptor 5M	2	pcs			
3	Computer Unit					
3.a	Processor: a. CPU Architecture Technology: Processor model should at least be the latest release b. Base Speed Frequency: 2.5GHz, up to 4.9 GHz c. Cores: ≥ 8 Cores d. Cache: ≥ 16MB Cache Operating System: a. Type: Latest Syable Proprietary OS 64-bit b. Version: Professional version (Must have the capability to join Active Directory)	1	pcs			

3.b	Motherboard Cpu (max support): i9 -Socket:1200 -Chipset: Intel® B560 Chipset -Ddr4 memory compatible -Memory Channel: Dual -Dimm slots:4 -Max memory (gb):128 -Pci-e x 16:2 -Pci-e x 1:1 -Sataiii:6 -M.2 slot:3 -Lan:1x Realtek® 8125B 2.5G LAN -Wifi & bluetooth: Intel® Wi-Fi 6E AX210	1	pcs			
3.c	Memory a. Capacity: ≥ 16 Gb DDR4 b. Speed: DDR4-3200mhz	2	pcs			
3.d	System Disk PCIE 3x4 512GB	1	pcs			
3.e	Storage SSD 2.5" 7mm SATAIII 1TB	1	pcs			
3.f	GPU Core Clock: ≥ 1785 Mhz Memory Clock: ≥ 14000 MHz Memory Size: ≥6GB Memory Bus: ≥192 bit PCB Form: ATX Power Connectors: 8 Pin Output: Display port 1.4*3 HDMI - 2.0b*1	1	pcs			
3.g	Casing	1	pcs			
3.h	PSU Type: ATX12V v2.4 Support MB Sync 5V 3-pin Addressable (Digital) Support C6/C7 power state AC Input: 110-130V;220-240V DC Output: +3.3V / +5V / +12V / +5Vsb Total Power: 500 W	1	pcs			
3.i	Monitor Panel Type: IPS Ratio: 16:09 Size: ≥ 23.8 inch Resolution: 1920 x 1080 Brightness: 220cd/m2 View Angle: ≥ (178(H), ≥ 178°(V)) Response Time: 11ms Refresh Rate: 75Hz Audio & Video Port: 1 VGA + 1H + Audio Out Power Input: 12V 2.5A Power Type: Adapter Vesa: 75 x 75	2	pcs			
3.j	Keyboard and Mouse	1	pcs			
3.k	UPS 1000VA AC Auto Restart Cold start function Input Voltage Range 160-Vac-290Vac Output Capacity 500W 220/230/240Vac Frequency Range 50/60Hz Transfer Time 2-6ms Battery Type 12V/7Ah x 1	1	pcs			

3.l	Table Frame: Steel Length: 120 cm Width: 60 cm Height: 75 cm Max Load: 100 kg/ 220 lbs	1	pcs		
3.m	Power Extension Cord Wheel Type Power Strip 3 universal outlet Max Length: 15M Max Load: 2500 watts (10A) Rated Voltage: 250V	1	pcs		
4	Electrical Outlet 6 outlets -2 gang x 3 surface type x 3 #12 THHN 15M, Conduit, 20A CB)	1	pcs		
5	Installation Cost: (Please see attached plan for more specific details)				
5.1	Labor	1	lot		
	Skilled; Manpower (6)				
	Unskilled; Manpower (4)				
5.2	Materials				
	Installation of Wall Mount TV Bracket '-Video Wall Bracket 55" Material: Cold-rolled steel plate Surface Treatment: Electrostatic Spraying VESA: ≥600mm(H) x 400mm(V)	4	pcs		
5.3	Equipment	1	lot		
	Minor Tools (10% of labor cost)				
OTHER REQUIREMENTS		<small>COMPLIANCE please check (✓) whether can comply or not, no check mark will mean non-compliance</small>		REMARKS	
		<small>Can Comply</small>	<small>Cannot Comply</small>		
1	Service Provider shall submit Statement of Work Accomplished and progress photos as a requirement of the billing request;				
2	5% Retention Fee;				
3	The delivery and installation period is within 15 calendar days upon receipt of the Purchase Order. When the last day of delivery falls on a weekend/holiday, the deadline shall be on the next working day;				
4	Delivery place is at DSWD-CAR #40 Northdrive Baguio City.				
5	Service Provider must have Active Landbank Account for Payment Purposes. For other banks, service charge will be deducted upon payment on the account				
TOTAL PRICE					
PAYMENT SHALL BE MADE THRU LANDBANK OF THE PHILIPPINES					

• Award shall be made per:

Lot basis Total Quoted Price

*Note: **NO GIFT ALLOWED**. Pursuant to RA 6713, otherwise known as the Code of Conduct and Ethical Standards for Public Officials and Employees. The DSWD reserves the right to reject any or all offers at no costs, waive any therein and accept the offer most advantageous to the government.*

Sir:

After having carefully read and accepted your terms and conditions, I / We submit our bid on the item/s quoted above.

Signature of
supplier/representative over
printed name: _____

Name of Firm/Dealer/Contractor: _____

(This will be the name of the CHEQUE to be Issued)


Name and Signature of Convasser

Address: _____
Email Address: _____

Contact Number/s: _____

PhilGEPS Registration Number: _____


VUB/sjmi

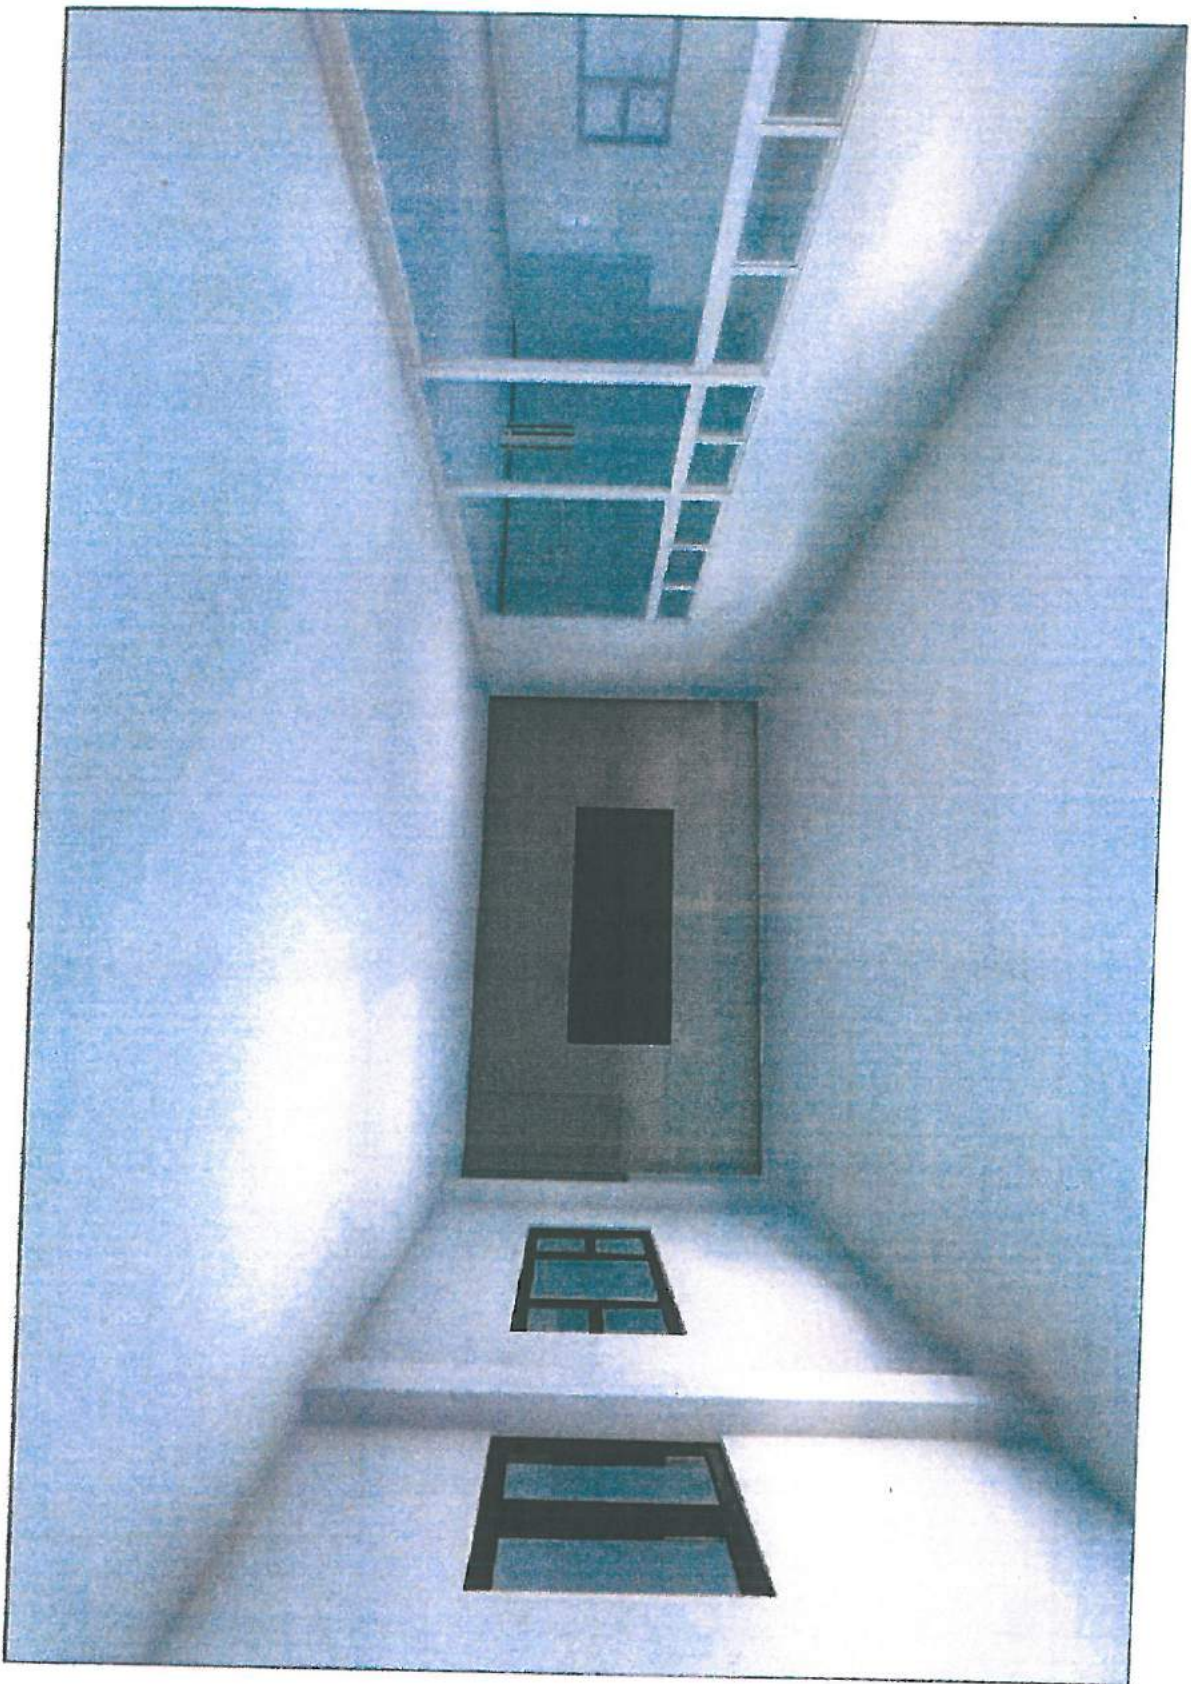

01
A101
SCALE
PERSPECTIVE
N15



ADMINISTRATIVE DIVISION
FIELD OFFICE CAR

DSWD-06-02-05 REV. 01 22 FEB 2011

PROJECT NAME:

**VISUAL AND AUDIO SYSTEM OF THE
MULT-PURPOSE HALL OF RHMG PHASE II**

LOCATION:

#40 NORTH DRIVE BAGUIO CITY

SHEET CONTENT:

AS SHOWN

APPROVED BY

LEO L. GARCILLA

Regional Director

CONFORMED BY

ENRIQUE J. GASCON JR.

Assistant Regional Director for Administration

CHECKED BY

HANRET C. MATYONA

FOU II ARCHT

PREPARED/DESIGNED BY

ANGEL D. MADAY

Engineer II EOWS


PROJECT/TA No.:

DATE SUBMITTED:

DRAWING STATUS

DATE **DESCRIPTION/REVISIONS** **BY**

PLAN CATEGORY	SHEET NUMBER	PAGES SIZE
A	1 / 4	A4

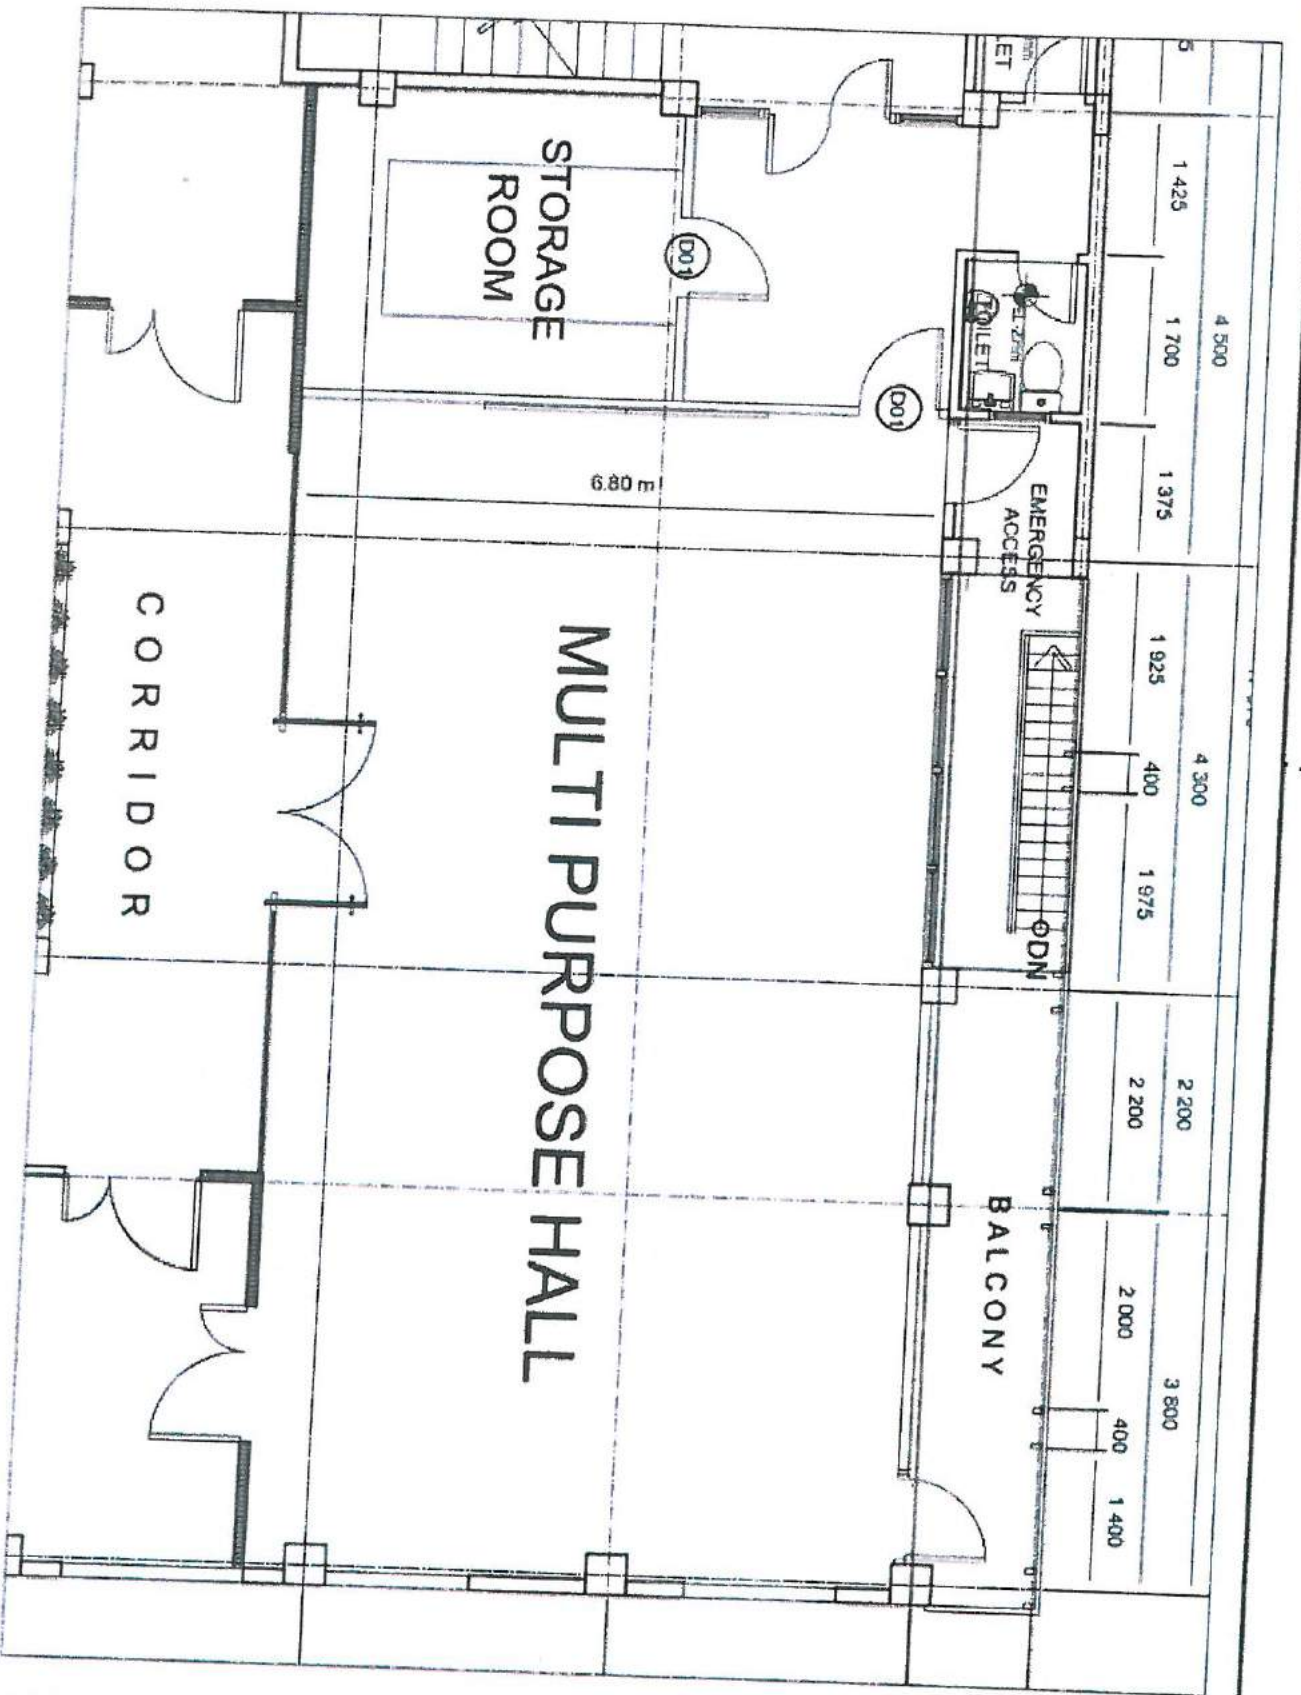

01 FLOOR PLAN
A 02 STATE 615

DSWD Field Office & Utilities Administrative Region - 49 North Drive, 2700 Baguio City, Philippines
 Email: regional@dswd.gov.ph Tel. No. (6374) 426 4501 462 0439 (6302) 306 4320
 Mobile No. (63917) 871 0001 273 0123



ADMINISTRATIVE DIVISION
FIELD OFFICE CAR
 DSWD-6-46-467 RIV. No. 22 Dec. 2011

PROJECT NAME:
 VISUAL AND AUDIO SYSTEM OF THE
 MULTI-PURPOSE HALL OF RHWC PHASE

LOCATION:
 #40 NORTH DRIVE BAGUIO CITY

SHEET CONTENT:

AS SHOWN

APPROVED BY

LEO L. DE VITORIA
 Regional Director

CONFERMED BY

ERIC D. H. GARCIA JR.
 Assistant Regional Director for Administration

CHECKED BY

HANILET C. MAYONA
 JOB # 612816

PREPARED/DESIGNED BY

ANGELINE M. MADAY
 Engineer R. EOMAS

PROJECT NO.
DATE SUBMITTED:
DRAWING STATUS

DATE DESCRIPTION/REMARKS BY

PLAN CATEGORY SHEET NUMBER PAPER SIZE

A 214 A4



**ADMINISTRATIVE DIVISION
FIELD OFFICE CAR**

DSWD 64-46-007 REV. 01 22 FEB 2021

PROJECT NAME:

**VISUAL AND AUDIO SYSTEM OF THE
MULT-PURPOSE HALL OF BHWG PHASE I**

LOCATION:

#40 NORTH DRIVE, BAGUO CITY

SHEET CONTENT:

AS SHOWN

APPROVED BY

LEO L. QUINTILLA
Regional Director

CONFORMED BY

ENRIQUE N. GARCON JR.
Assistant Regional Director for Administration

CHECKED BY

HANKEI C. MAYONA
FOIA BICMANS

PREPARED/DESIGNED BY

ANDREW MAJADAY
Engineer II, BOMS


PROJECT/TIA NO.:

DATE SUBMITTED:


DRAWING STATUS

DATE DESCRIPTION/REMARKS BY

PLAIN CATEGORY	SHEET NUMBER	PAPER SIZE
A	3 / 4	A4

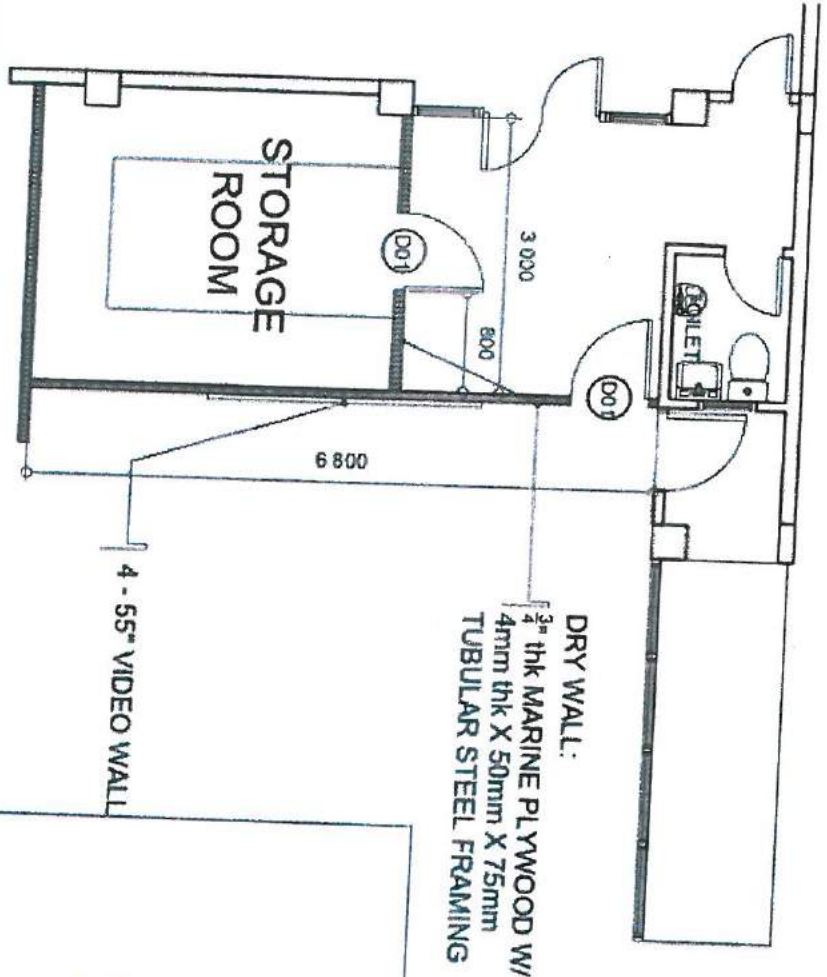

01 FLOOR PLAN
SCALE NTS

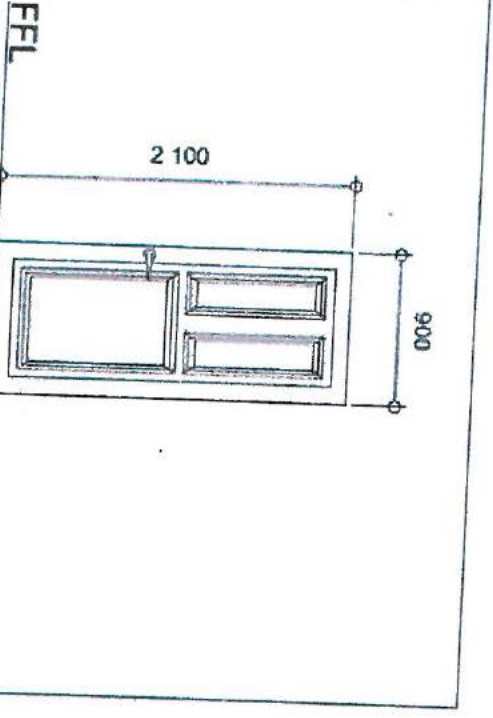

(D01) QUANTITY: 2.00 SETS

**50mm THK SOLID PANEL DOOR
50mm X 100mm SOLID WOOD DOOR JAMB
LEVER TYPE HEAVY DUTY DOOR KNOB
4 PAIRS SS 50mm X 75mm BALL BEARING
HINGES**

02 DOOR SCHEDULE
SCALE NTS

DSWD 13 Field Office Car Administration e Region, 40 North Drive, 3000 Baguio City, Philippines
E-mail: dswd@dswd.gov.ph, Tel. Nos: (63741) 446-5901 / 662-0430 / 637071338 / 4780
Mobile Nos: (0905) 5387888888888888



ADMINISTRATIVE DIVISION
FIELD OFFICE CAR

PROJECT NAME:
VISUAL AND AUDIO SYSTEM OF THE
MULTI-PURPOSE HALL OF RHWC PHASE
DRAWN: ASAP-007 REV. 01 22 DEC 2011

LOCATION:
#40 NORTH DRIVE BAGUIO CITY

SHEET CONTENT:
AS SHOWN

APPROVED BY:
[Signature]

XEO L. GONZALEZ
Regional Director

CONFORMED BY:

ENRIQUE H. SANCHEZ JR.
Assistant Regional Director for Administration

CHECKED BY:

HAMILET C. MATYONA
FOUR ARCHT

PREPARED/DESIGNED BY:

ANGELINA TABADAY
Engineer R. ROOMS


PROJECT/T/A No.:
DATE SUBMITTED:
DRAWING STATUS

DATE DESCRIPTION/REMARKS BY


PLAN CATEGORY	SHEET NUMBER	PAPER SIZE
A	4 / 4	A4

DRY WALL:
3/4" thk MARINE PLYWOOD W/
4mm thk X 50mm X 75mm
TUBULAR STEEL FRAMING
SPACED @ 0.4m O.C.

4 - 55" VIDEO WALL

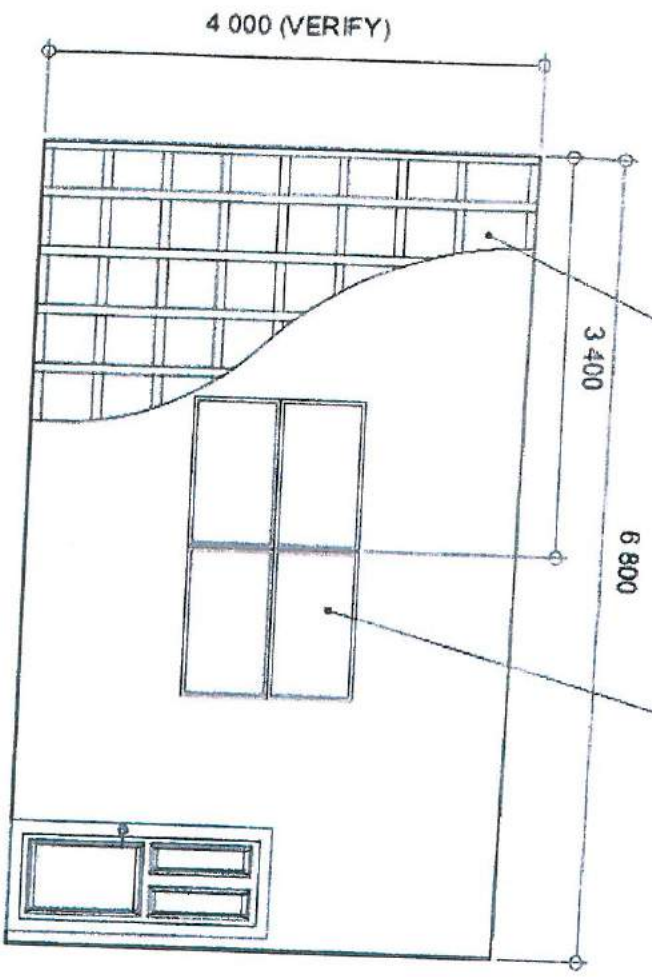

01
A 04
SCALE
FRONT ELEVATION
NTS

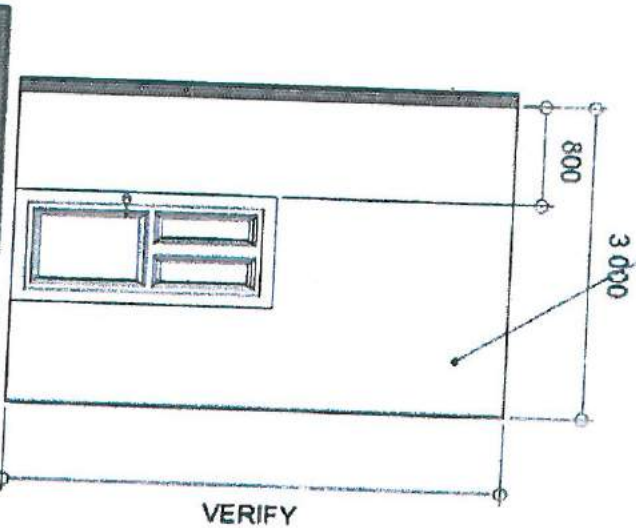

02
A 04
SCALE
RIGHT SIDE ELEVATION
NTS



ADMINISTRATIVE DIVISION
FIELD OFFICE CAR

DNWD-MS-OF-001 REV. 01 22 NOV 2011

PROJECT NAME:

VISUAL AND AUDIO SYSTEM OF THE MULTI-PURPOSE HALL OF RING PHASE I

LOCATION:

#40 NORTH DRIVE BAGUIO CITY

SHEET CONTENT:

AS SHOWN

APPROVED BY:

KEO L. QUINTILLA
Regional Director

CONFORMED BY:

ENRIQUE H. GATSON JR.
Assistant Regional Director for Administrative Services

CHECKED BY:

HAMLET C. MALAYONA
IN-CHARGE

PREPARED/DESIGNED BY:

ANGEL M. ADADAY
Engineer II BOMIS

PROJECT No. _____


DATE SUBMITTED: _____

DRAWING STATUS

DATE DESCRIPTION/REVISIONS BY

PLAN CATEGORY SHEET NUMBER PAPER SIZE

E 1/1 A4

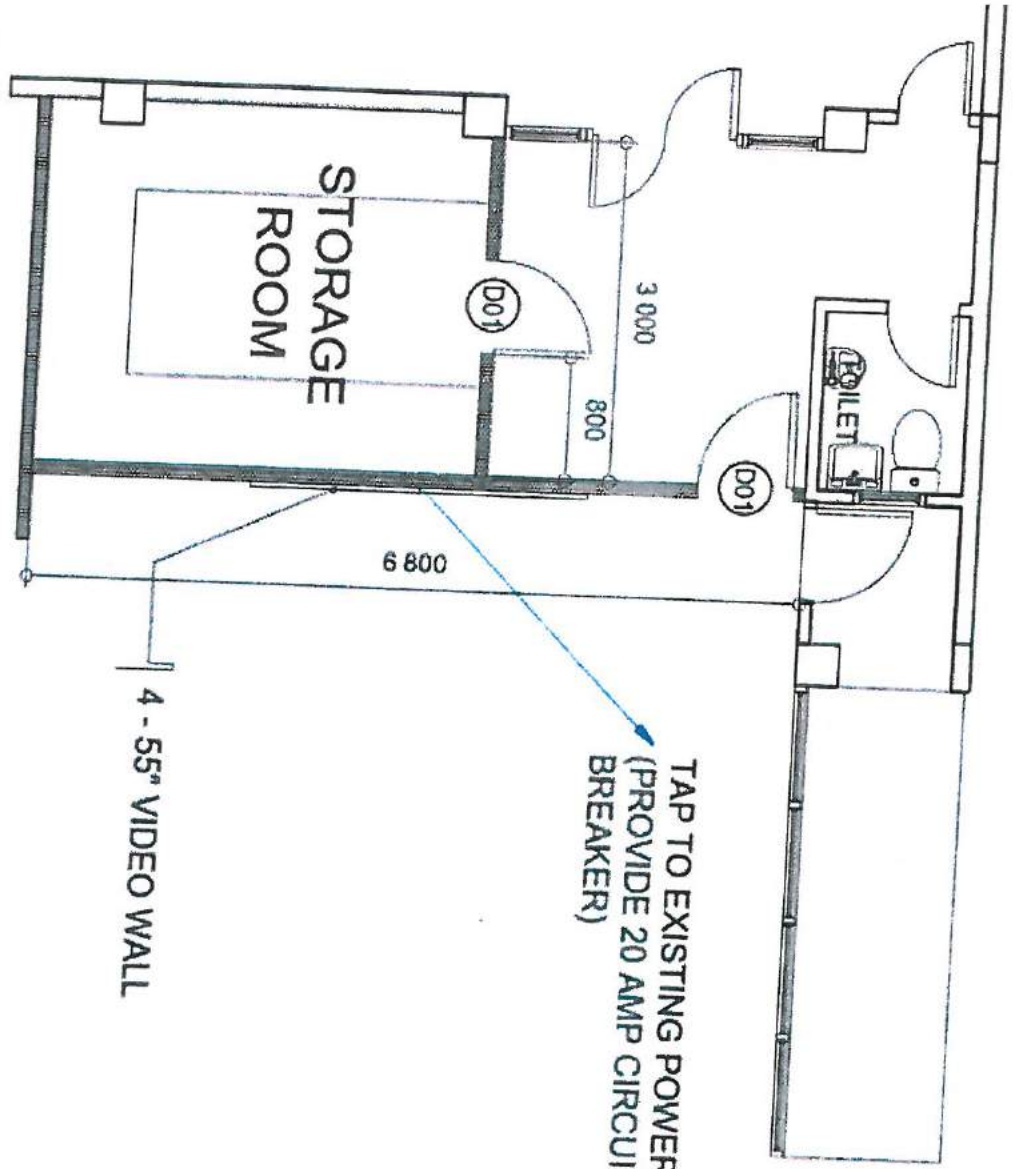

ELECTRICAL PLAN

01
E 01

SCALE

NTS

1251117 and Prince & Associates Administrative Region 49 North Drive, 2nd Floor Baguio City, Philippines
E-mail: princeandassociates@princeandassociates.com.ph Tel. No: +6374414464800 / 6474414464800
Mobile No. +639174713553 / 639174713554